

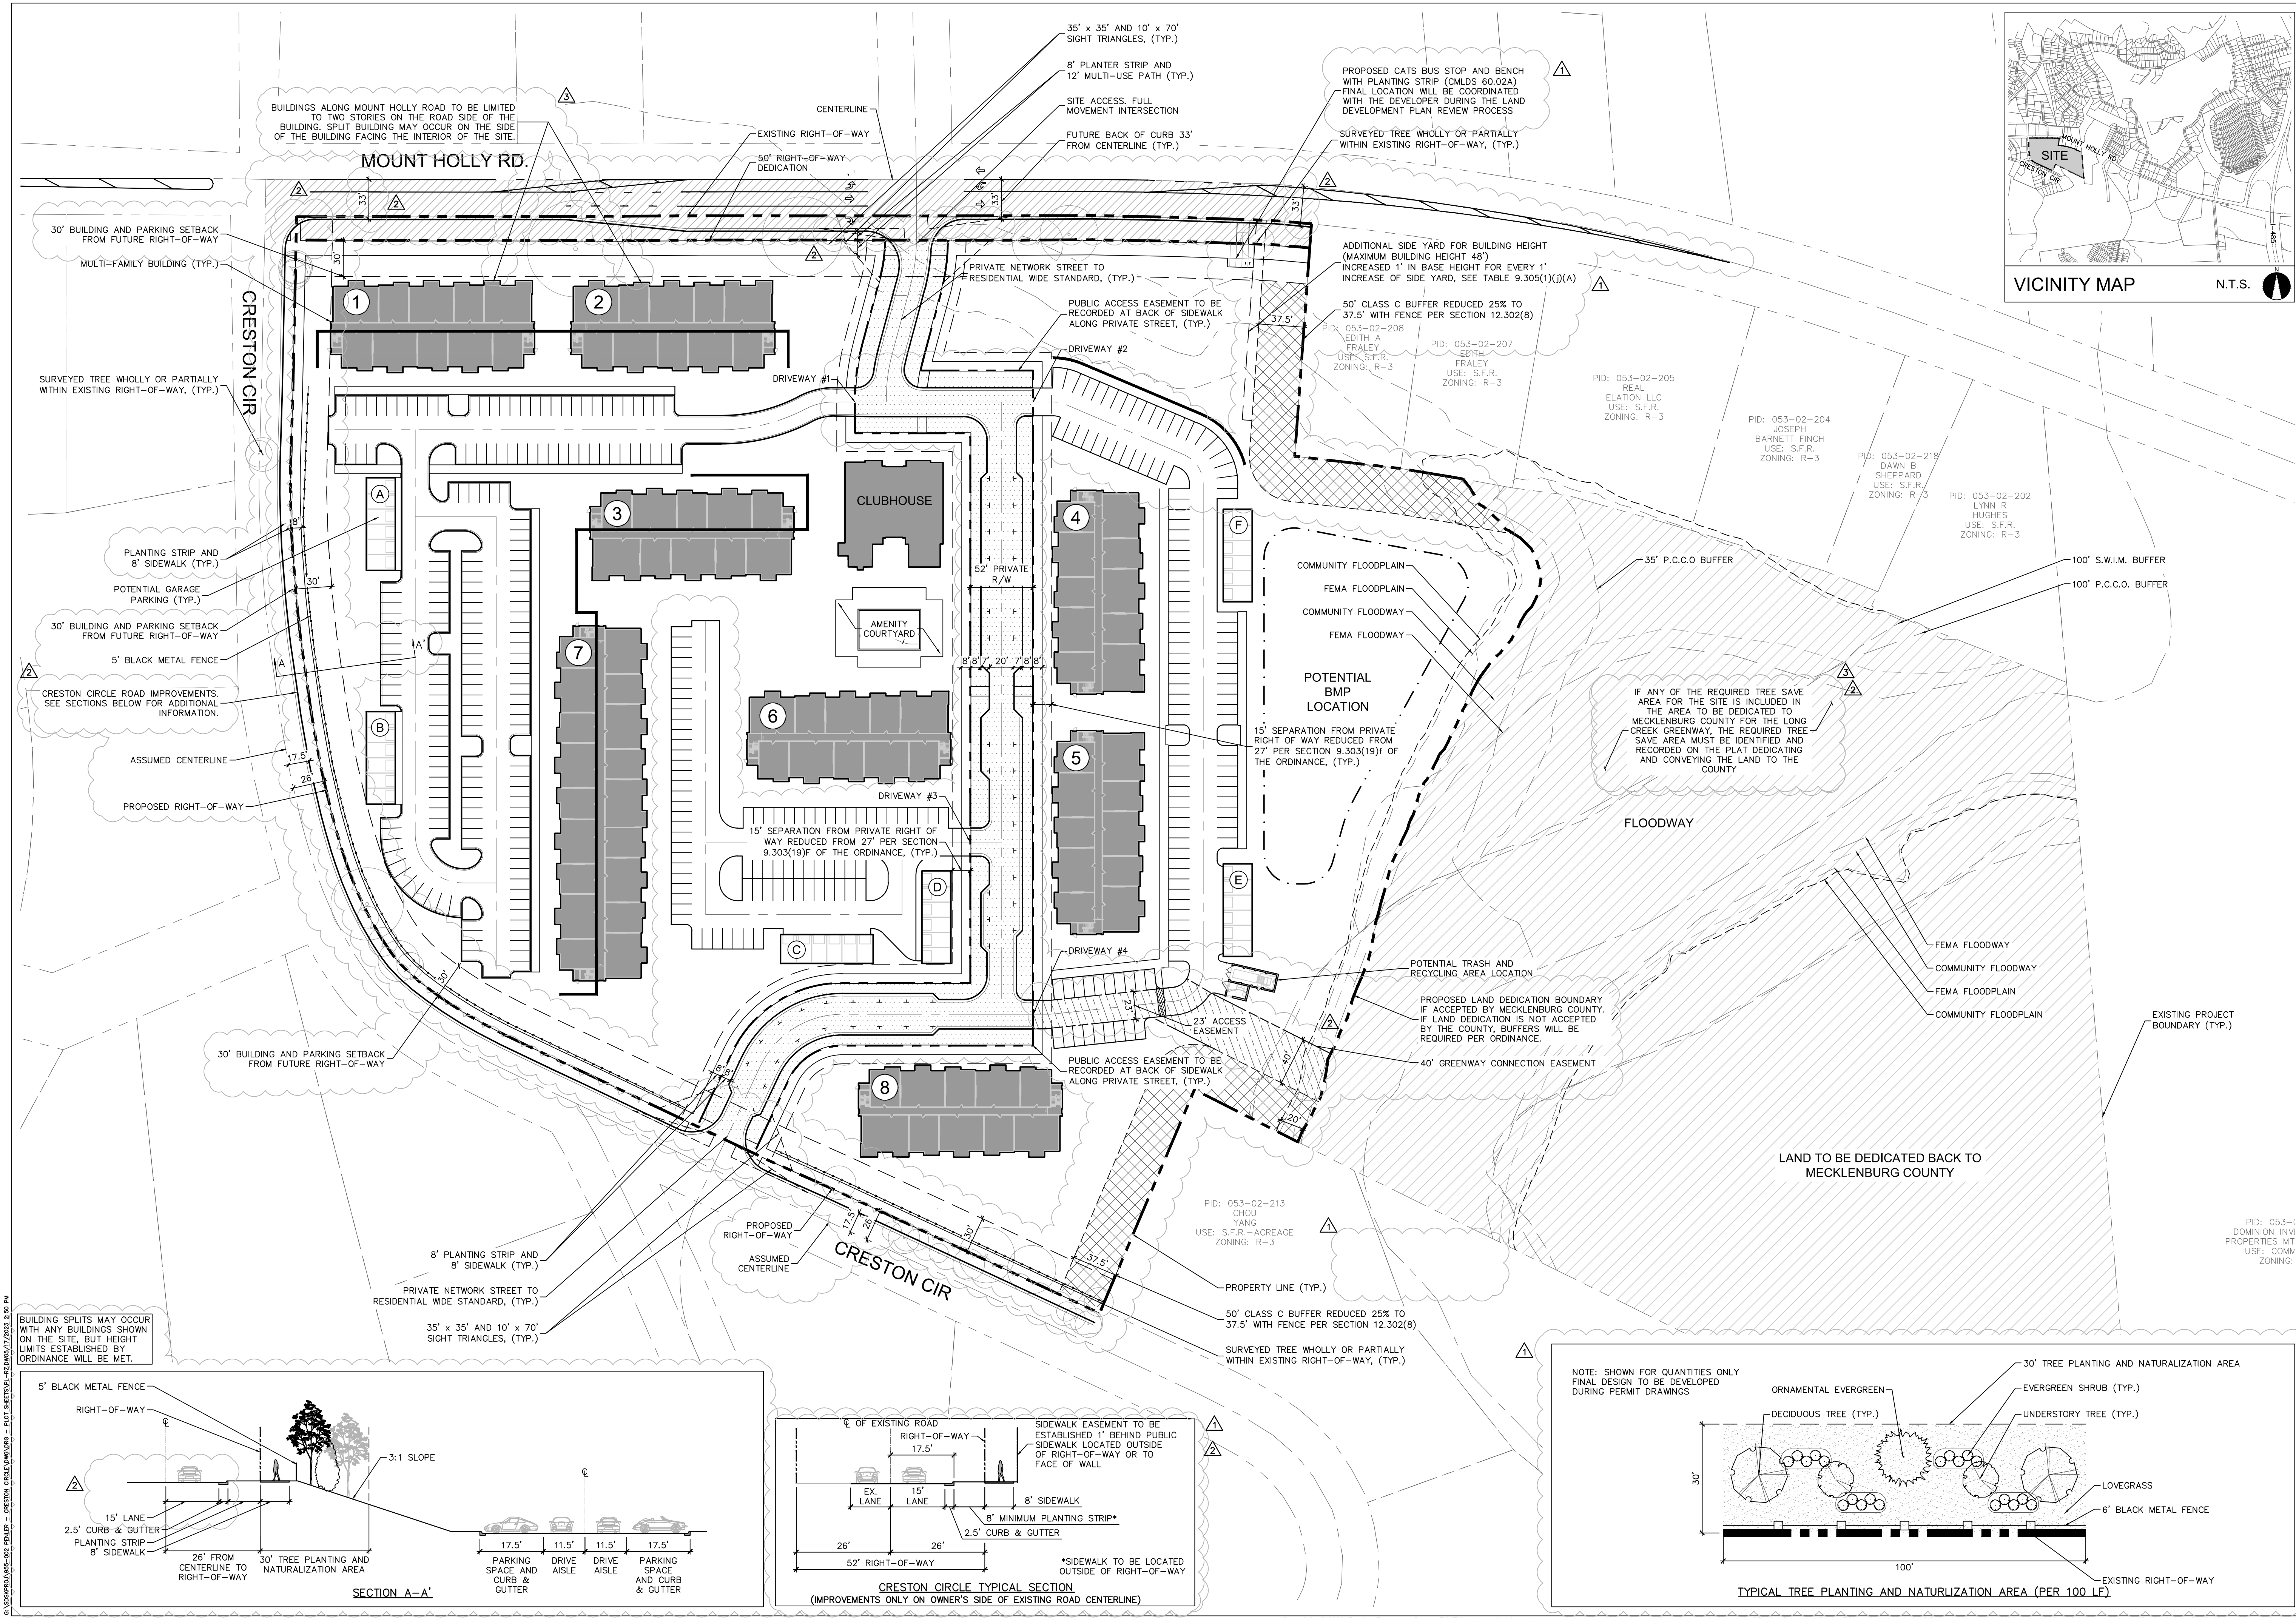
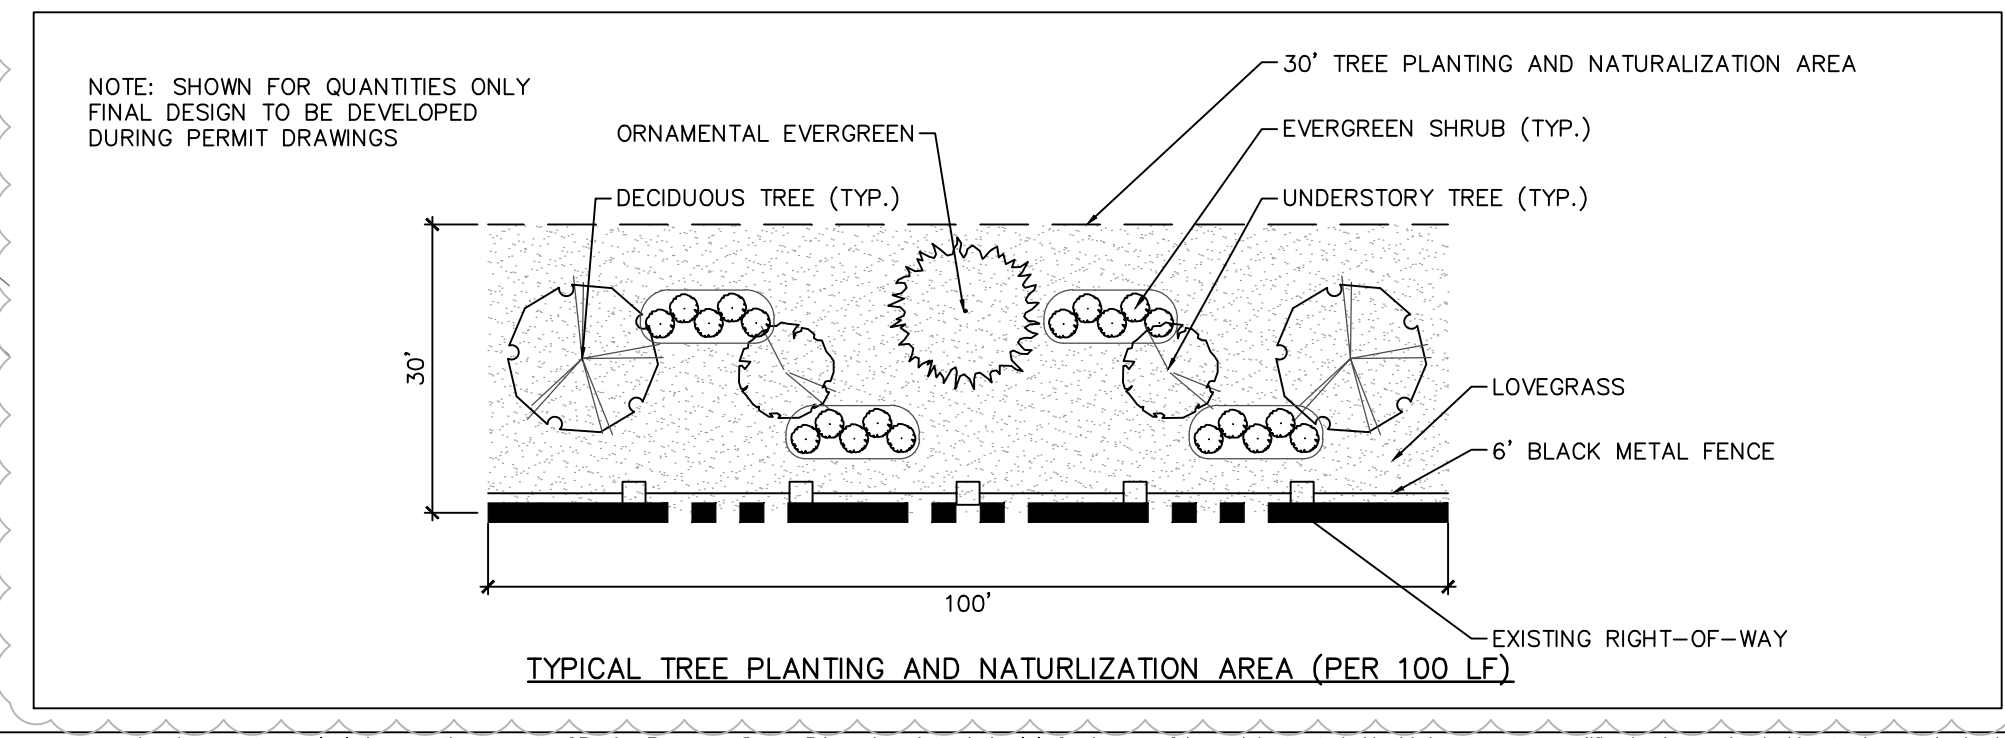


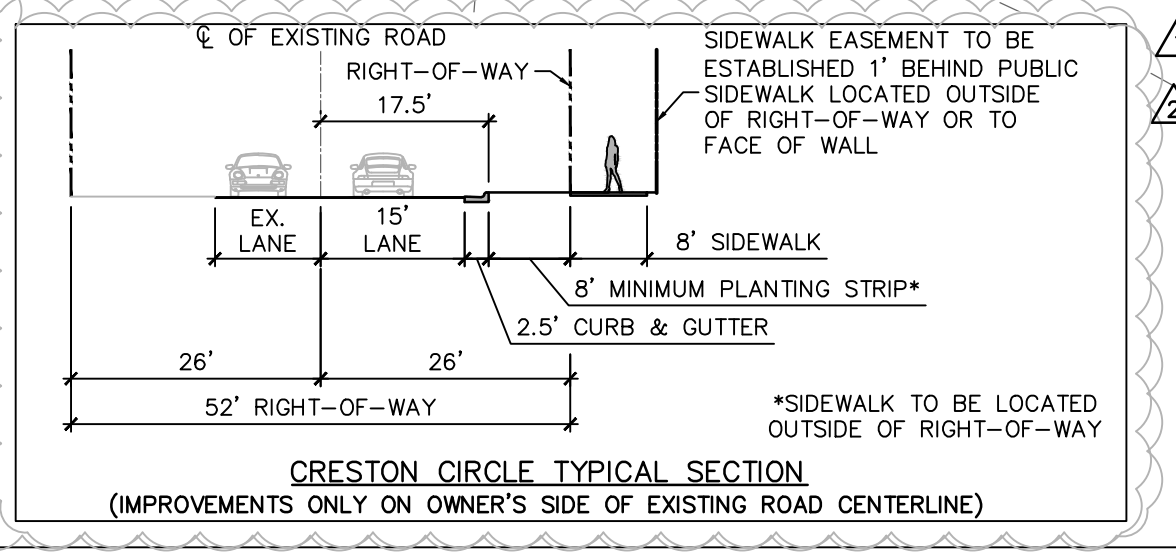

0:\projects\05-002\05-002_PENLER - CRESTON CIRCLE\DWG - PLT\05-002_PENLER - CRESTON CIRCLE.dwg - 17/2022 2:00 PM

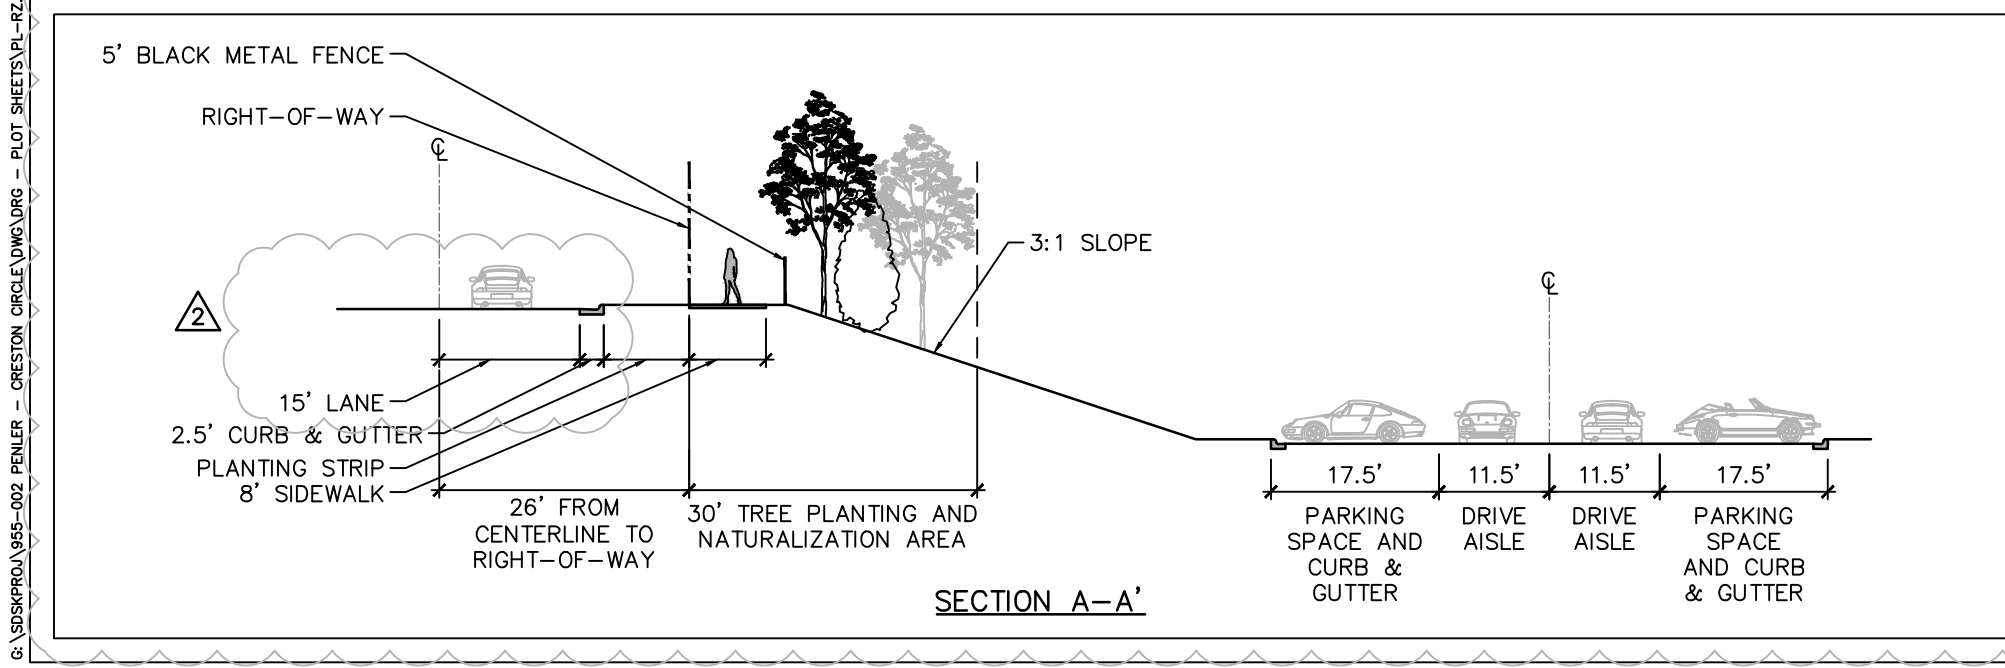

drG
DESIGN
RESOURCE
GROUP

LANDSCAPE ARCHITECTURE
CIVIL ENGINEERING
TRANSPORTATION PLANNING

2459 Wilkinson Blvd, Ste 200 Charlotte, NC 28208
704.343.0608
www.drgrp.com

VICINITY MAP
N.T.S.

REZONING PETITION
FOR PUBLIC HEARING
2022 - 160

REZONING DOCUMENTS

CRESTON CIRCLE
CHARLOTTE, NORTH CAROLINA

PENLER
42964 PEACHTREE RD NW, STE 275
ATLANTA, GA 30305
704.576.6500

SCHEMATIC
SITE PLAN

30 0 30 60
SCALE: 1" = 60'

PROJECT #: 955-002
DRAWN BY: DK
CHECKED BY: SVK

MAY 17, 2023

REVISIONS:
SITE AND NOTE REVISIONS
REVISIONS PER STAFF COMMENTS
REVISIONS PER STAFF COMMENTS